


CITY OF COLUMBUS, OHIO
 DEPARTMENT OF PUBLIC UTILITIES – DIVISION OF POWER AND WATER
**Street Lighting Improvements for
 BROAD MEADOWS
 (CIP)**

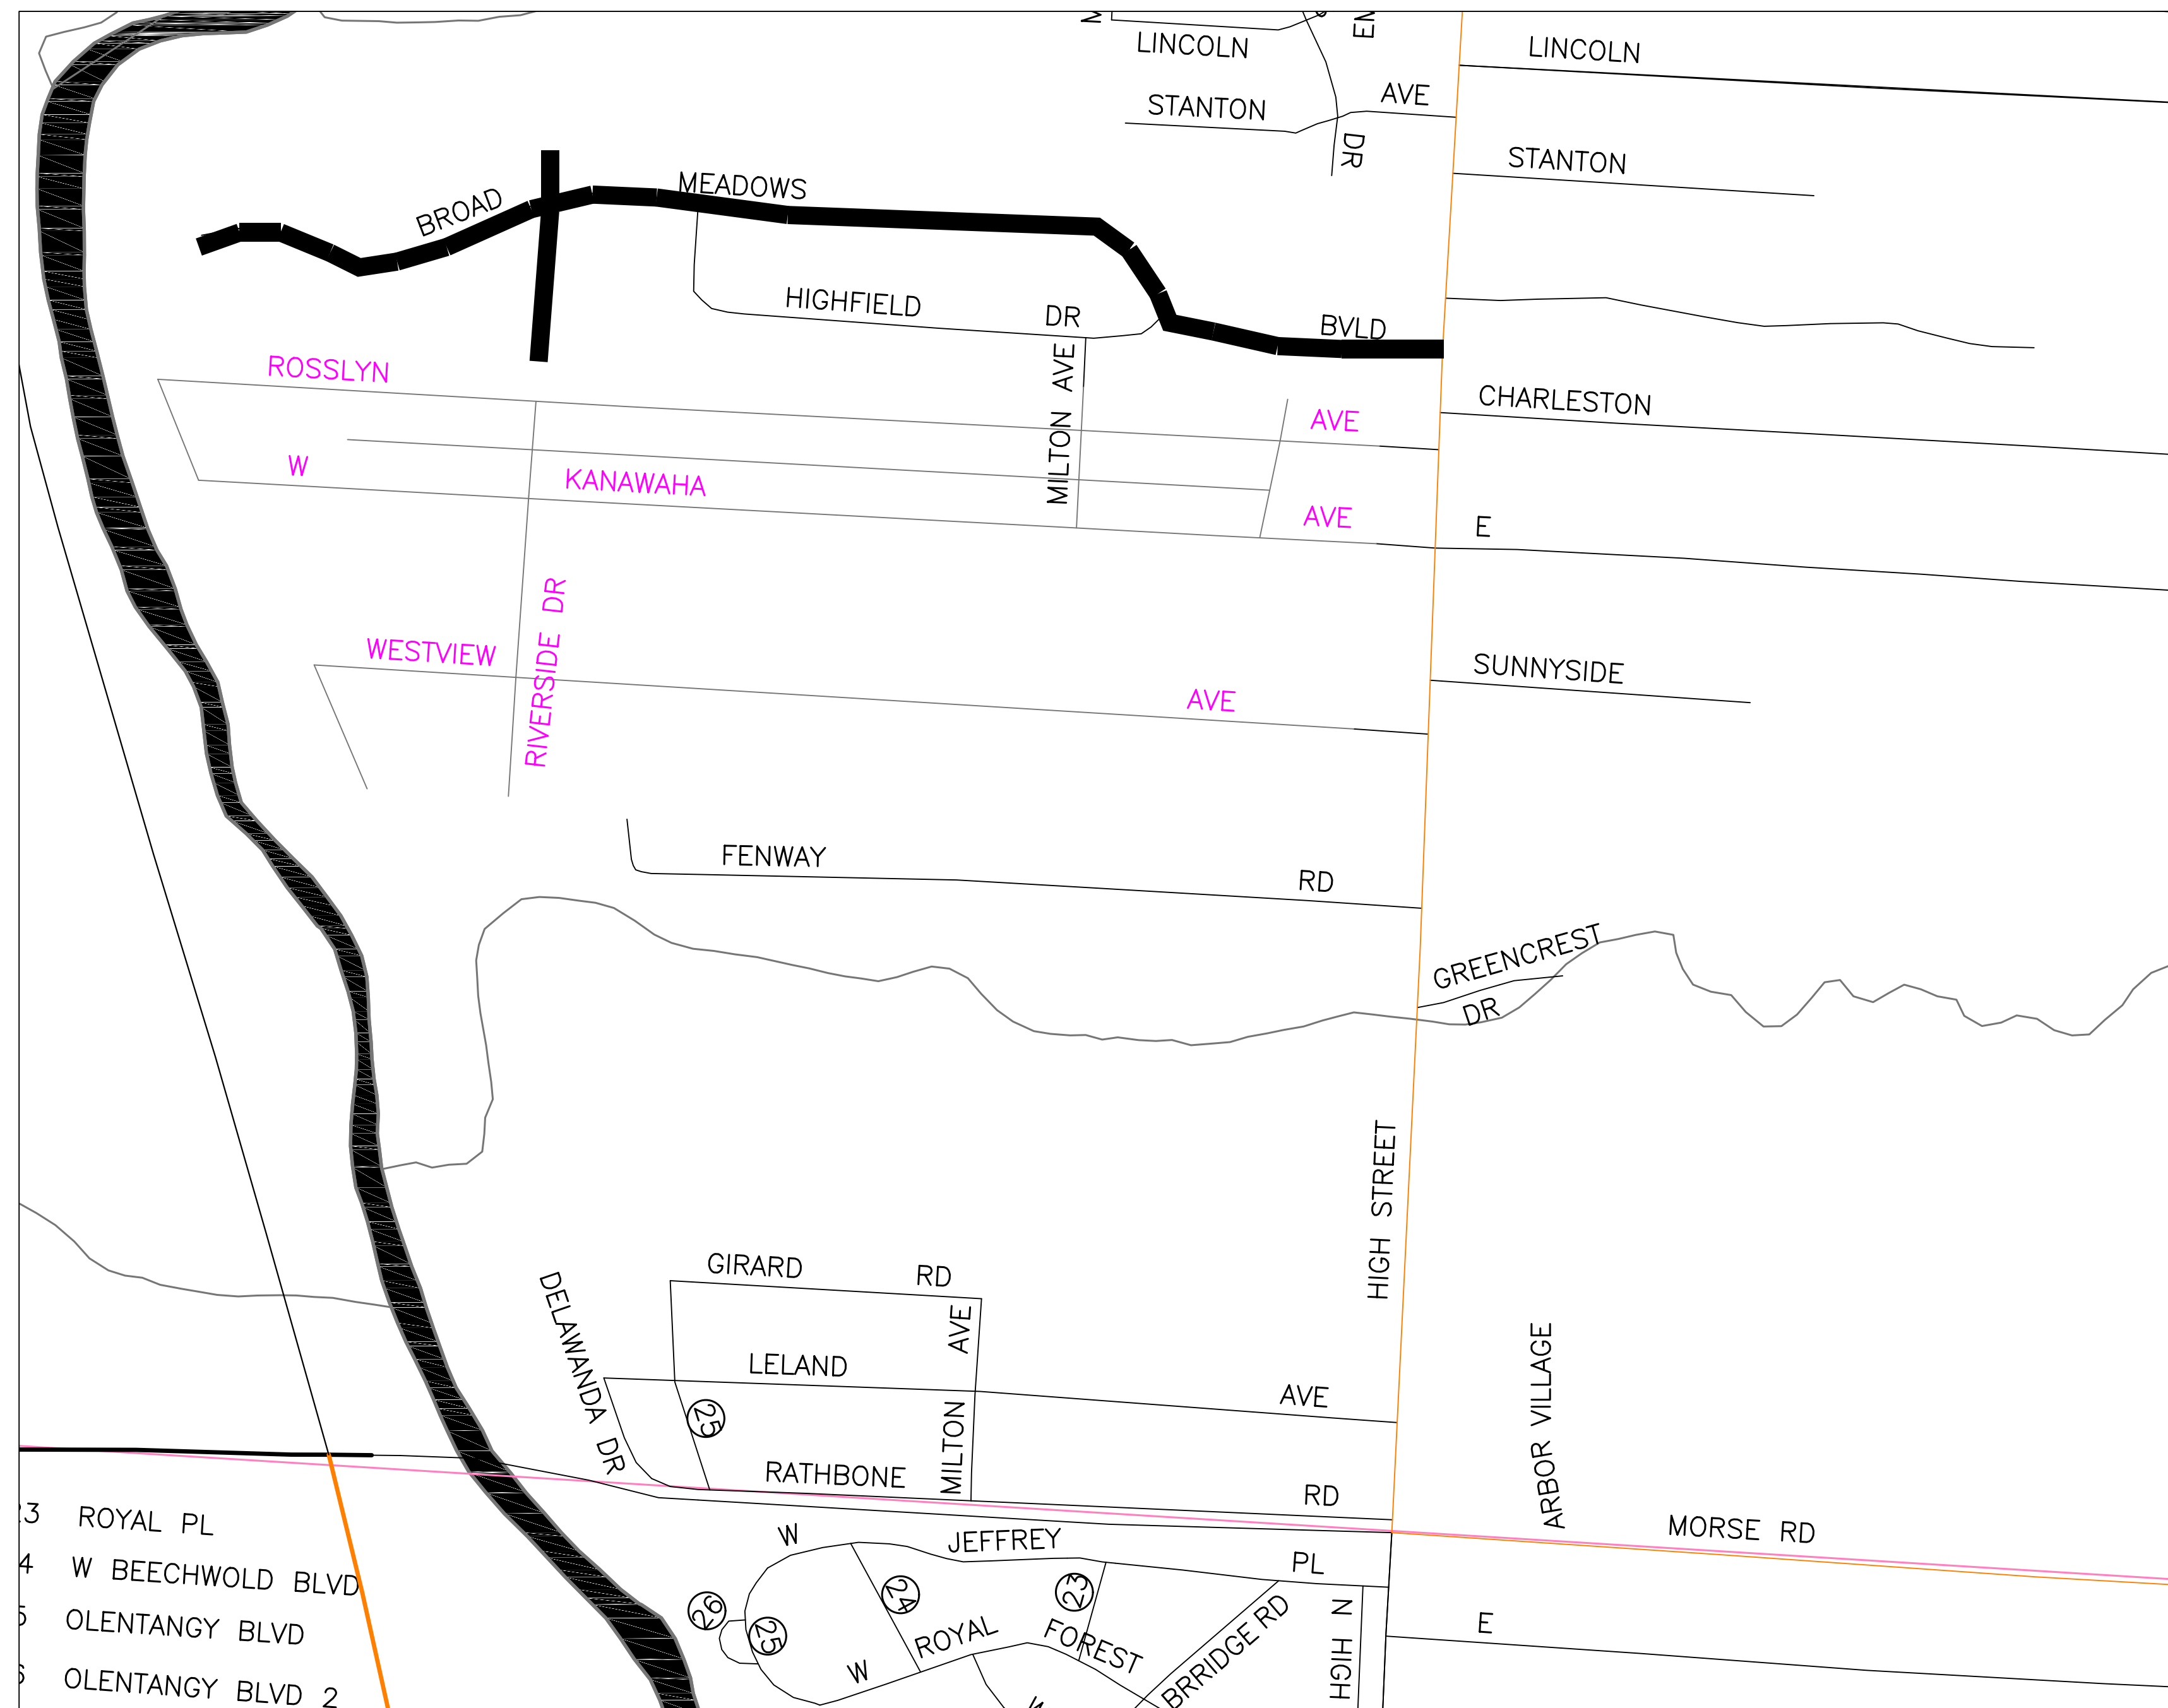

_____ DIRECTOR OF PUBLIC UTILITIES	_____ DATE
_____ DIRECTOR OF PUBLIC SERVICE	_____ DATE
_____ ADMINISTRATOR, DIV. OF POWER AND WATER	_____ DATE
_____ ADMINISTRATOR, DIV. OF SEWERAGE & DRAINAGE	_____ DATE
_____ DESIGN SECTION ENGINEER, DIVISION OF DESIGN AND CONSTRUCTION	_____ DATE
_____ CITY ENGINEER, ADMINISTRATOR DIVISION OF DESIGN AND CONSTRUCTION	_____ DATE

INDEX OF SHEETS


TITLE SHEET.....1
 GENERAL NOTES2
 DETAILS AND ESTIMATES.....3
 LIGHTING PLANS.....4-6

SCOPE OF WORK

INSTALL OVERHEAD
 480V STREET LIGHTING
TOTAL INSTALLATION
 29-100W HPS/480V STREET LIGHTS

COURTESY PHONE NUMBERS
 G - COLUMBIA GAS - 1-800-363-2764
 T - OHIO BELL TELEPHONE - 1-800-363-2764
 W - WATER SERVICE CENTER - 645-7788
 S - SEWER SHOP - 645-7102
 E - DIVISION OF POWER - 645-7627
 (DISPATCH CENTER)

UNDERGROUND UTILITIES
 TWO WORKING DAYS
 BEFORE YOU DIG
 CALL 1-800-362-2764 (TOLL FREE)
 OHIO UTILITIES PROTECTION SERVICE
 NON-MEMBERS
 MUST BE CALLED DIRECTLY

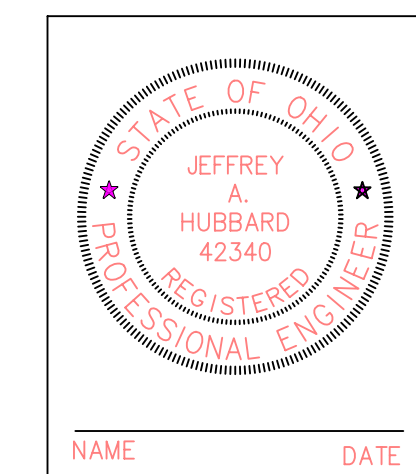

- 3 ROYAL PL
- 4 W BEECHWOLD BLVD
- 5 OLENTANGY BLVD
- 6 OLENTANGY BLVD 2

REVISIONS			MELP MUNICIPAL ELECTRIC LIGHT & POWER SYSTEM CITY OF COLUMBUS, OHIO DEPT. OF PUBLIC UTILITIES – DIVISION OF POWER AND WATER		
Street lighting improvements for BROAD MEADOWS (CIP)					
DRAWN BY: MO		DATE: 07/10	SPL NUMBER: 0810731		
APPROVED:					
DATE	INITIALS	DESCRIPTION	SCALE: NONE	SHEET: 1 OF 6	DWG.NO. 12E0632